

DEMOLITION NOTES:

1. CONTRACTOR TO FIELD VERIFY ALL ASPECTS OF BUILDING IN DEMOLITION AREAS AND DETERMINE EXTENTS OF SHORING AND BRACING REQUIRED SUCH THAT EXISTING BUILDING ELEMENTS TO REMAIN ARE NOT DAMAGED DURING DEMOLITION OR CONSTRUCTION.
2. CONTRACTOR IS TO COORDINATE ALL DEMOLITION WORK WITH ARCHITECTURAL PLANS AND NOTIFY ENGINEER OF RECORD IF THERE ARE ANY DISCREPANCIES.
3. EXISTING CONDITIONS AS SHOWN ON THESE PLANS ARE FROM LIMITED FIELD OBSERVATIONS, INCLUDING DIMENSIONS, AND NOTED ELEVATIONS. CONTRACTOR SHALL FIELD VERIFY ALL DIMENSIONS, ELEVATIONS, AND SIZES PRIOR TO ORDERING OF MATERIALS. ORDERING OF CMU, STEEL, WOOD, OR CONCRETE BY CONTRACTOR IMPLIES ACCEPTANCE OF DIMENSIONS.
4. TRENCHING FOR PLUMBING OR UTILITY PLACEMENT NOT SHOWN. CONTRACTOR TO REFERENCE ARCHITECTURAL, PLUMBING, AND ELECTRICAL PLANS FOR ANY TRENCHING REQUIREMENTS

LEGEND

xx/sx.x


DETAIL NUMBER

SHEET NUMBER

INDICATES EXISTING

INDICATES EXISTING TO BE MODIFIED

INDICATES DEMO

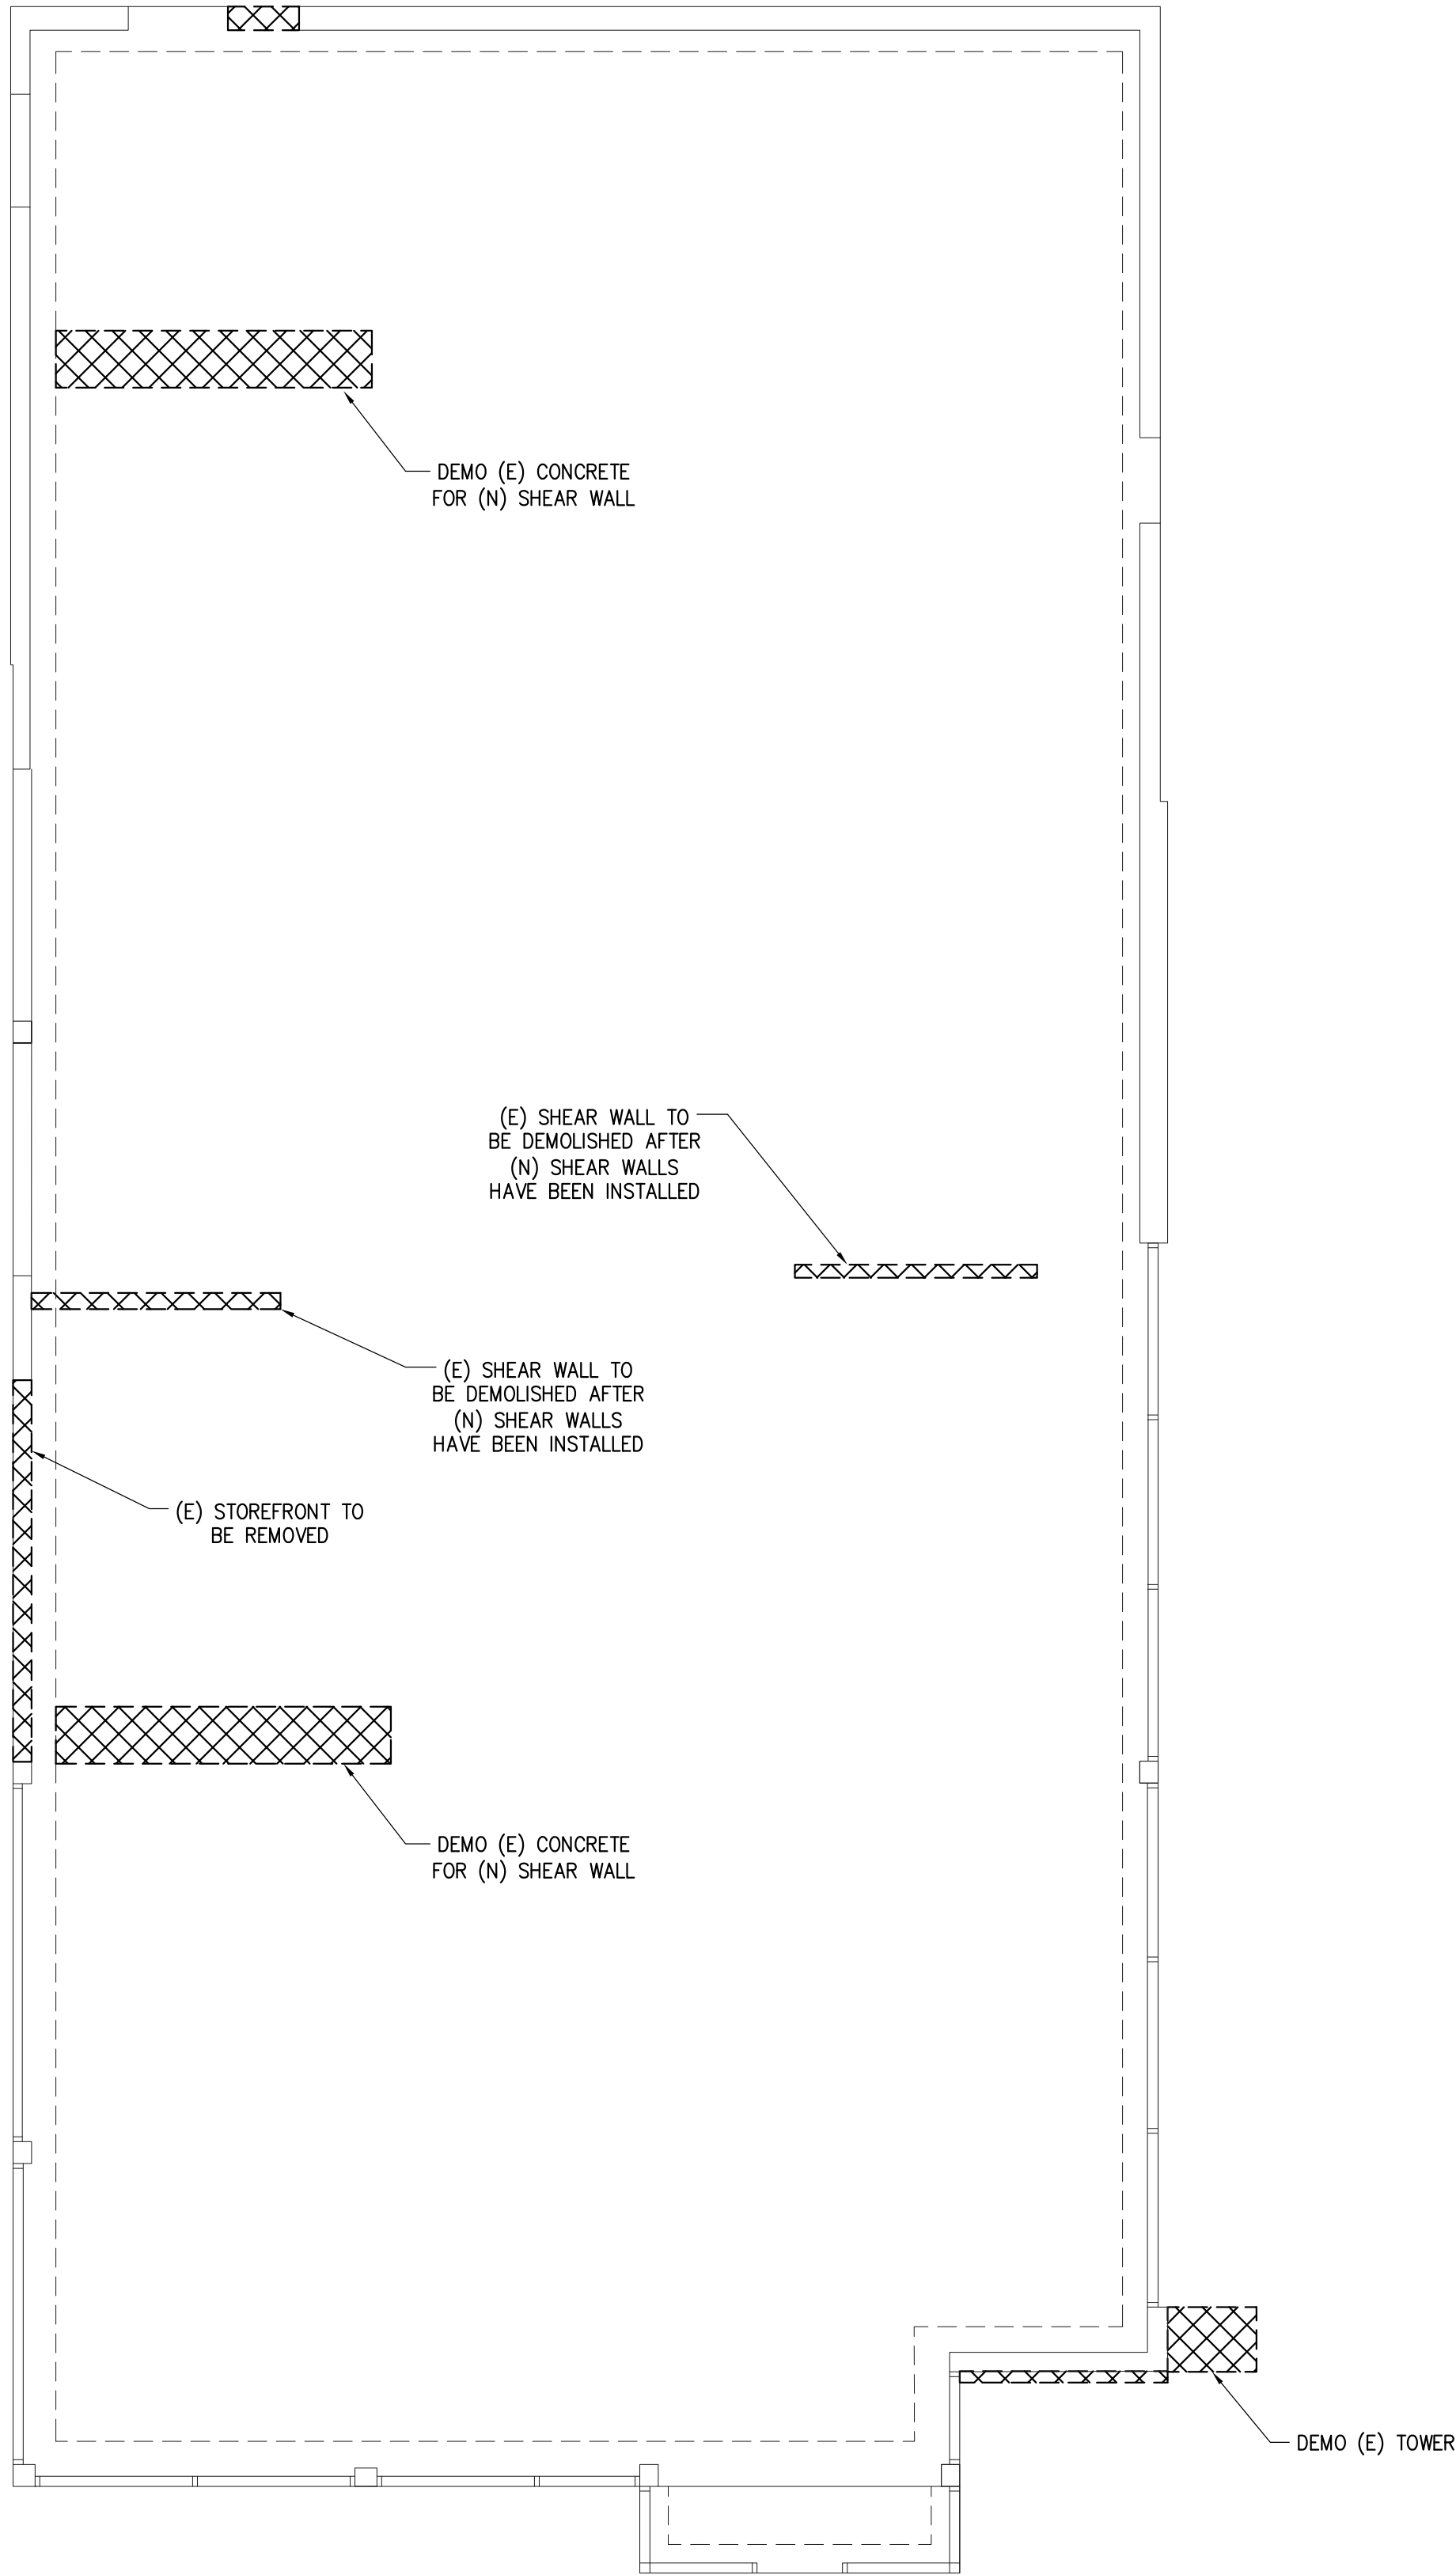

PANDA EXPRESS, INC.
1683 Walnut Grove Ave.
Rosemead, California
91770
Telephone: 626.799.9898
Facsimile: 626.372.8288

All ideas, designs, arrangement and plans indicated or represented by this drawing are the property of Panda Express Inc. and were created for use on this specific project. None of these ideas, designs, arrangements or plans may be used by or disclosed to any person, firm, or corporation without the written permission of Panda Express Inc.

REVISIONS:

ISSUE DATE:

1st	DEVELOPER REVIEW	07.15.19
2nd	SITE PLAN SUBMITTAL	08.26.19
3rd	SITE COMMENTS	09.05.19
4th	ISSUE FOR PERMIT	10.01.19
5th	ISSUE FOR BID	11.07.19

DRAWN BY: PM / KL / EA

PANDA PROJECT #: S8-20-D7163

ARCH PROJECT #: 19027

James F. Turner
Engineers, L.P.
Consulting Engineers
8340 Meadow Road, #160
Dall 108, TX 75231
214.750.2907
Job #82206
Cal. #C-5874-E

ALABAMA

REGISTERED

No. 14970

PROFESSIONAL

ENGINEER

JAMES F. TURNER

11/1/19

Heights Venture
ARCHITECTURE • DESIGN

HOUSTON DALLAS
1111 North Loop West, Suite 800 5741 Legacy Drive, Suite 320
Houston, Texas 77008 Plano, Texas, 75024
713 869 1103 V 972 490 7292 V

PANDA EXPRESS

2096 INTERSTATE DR.
OPELIKA, AL, 36801
3600 FSDT

TWW REMODEL

SD-100

FOUNDATION DEMO PLAN

TRUE WARM & WELCOME

BID ISSUE